

BASE4

BASE4
3858 GLADES ROAD, #31
BOCA RATON, FLORIDA 33434
1.720.125.4544 www.base-4.com

SEAL



GARRY VERMAAS, Ph.D., PE
2014.08.05
9011 EDGEWATER BEND
PARKLAND, FLORIDA, 33076



ISSUE:

Issued for Permit
08.05.2016

PROJECT: 16-018

Hampton Inn & Suites

New Stanton, PA 15672

OWNER:

Stanton Hospitality LLC

52 Blueberry Lane,
Grove City, PA 16127

No.	Issue Date	Project Status

DATE 2016.08.05

DRAWN BY SJ

CHECKED BY GWV

SCALE AS NOTED


PROJECT NO. B4-67-1603

SHEET NAME

THIRD FLOOR POWER
& LIGHTING PLAN

SHEET NO.


E203

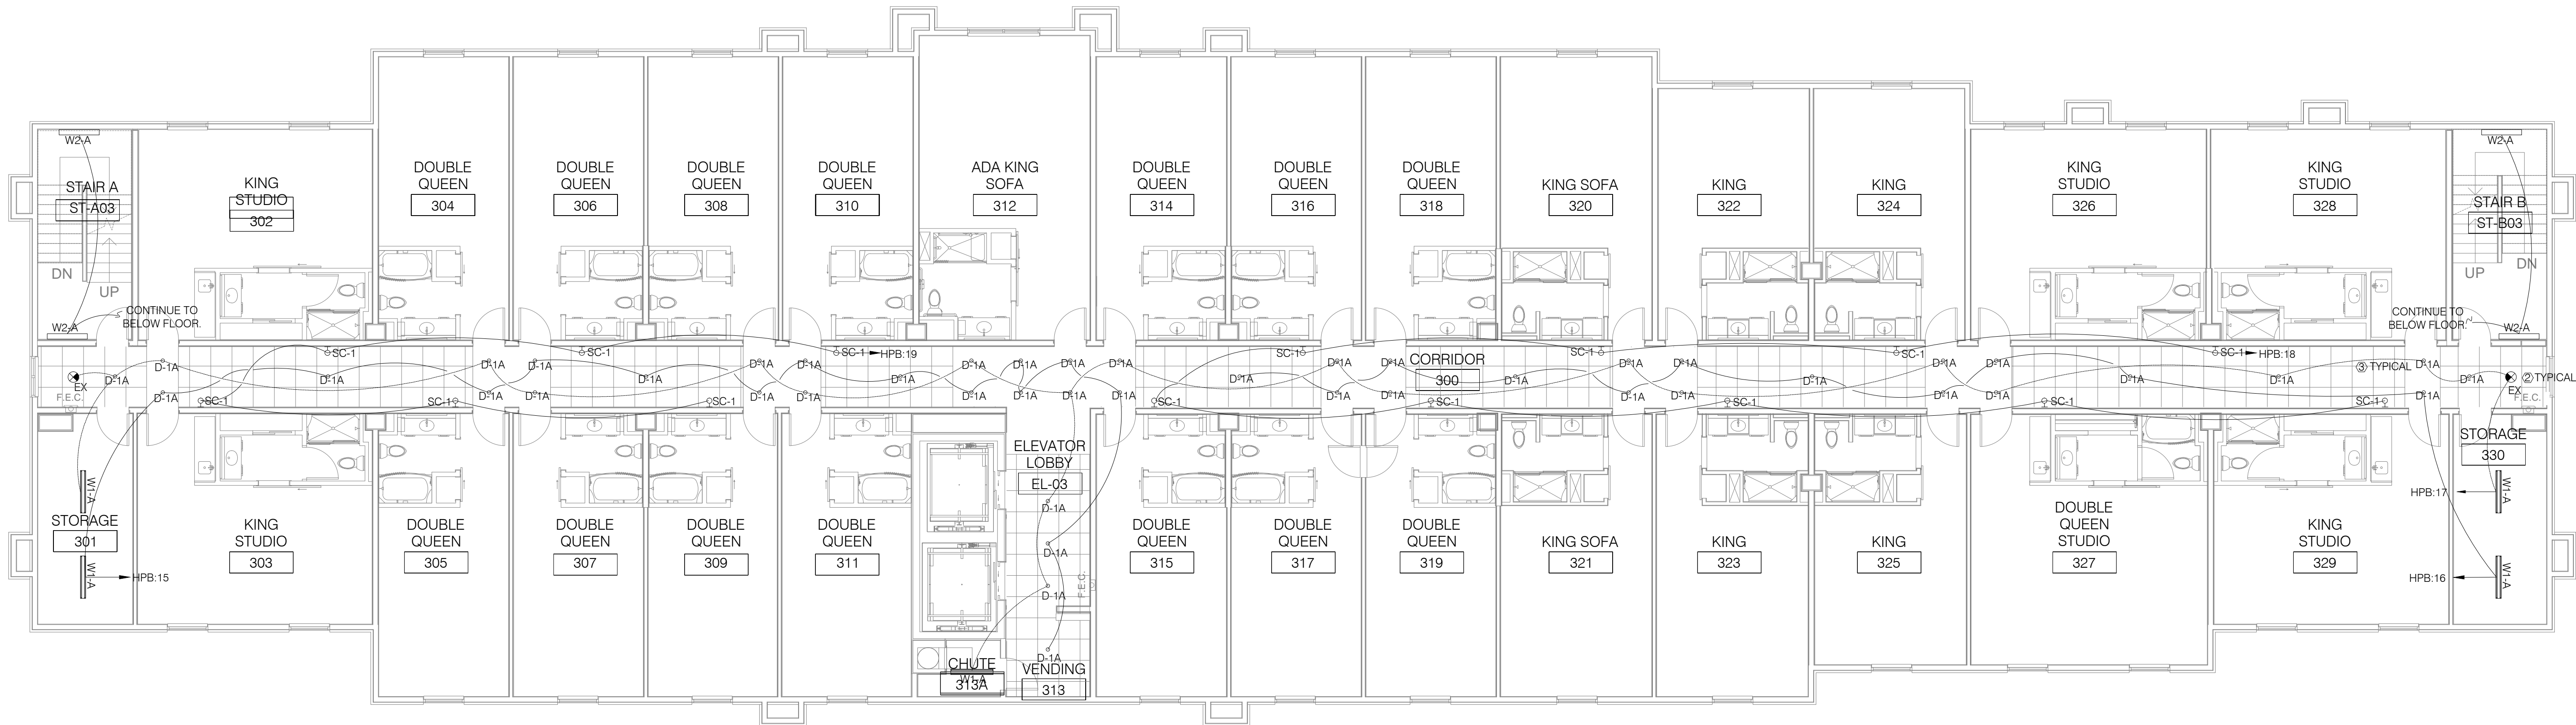

02 THIRD FLOOR LIGHTING PLAN
SCALE: 3/32" = 1'-0"

KEY NOTES

- HOUSE PHONE ONLY W/ AUTOMATIC DIAL TO FRONT DESK.
- FIRE/SMOKE DAMPER CONNECT TO FIRE ALARM SYSTEM. SEE MECHANICAL DWG FOR LOCATION AND REQUIREMENT. PROVIDE ELECTRICAL CONNECTION TO SMOKE/FIRE DAMPER FROM CKT HPA-48. TYPICAL FOR ALL FLOOR.
- CONTRACTOR SHALL ENSURE W-FI IS PROVIDED THROUGHOUT PUBLIC AREA.
- MAGNETIC DOOR-HOLD TIED TO THE BUILDING FIRE ALARM CONTROL PANEL. PROVIDE ELECTRICAL CONNECTION TO MAGNETIC DOOR-HOLD. SEE CKT HPA-52. TYPICAL FOR ALL FLOOR.
- J-BOX FOR LAUNDRY CHUTE DOOR INTERLOCK TO TIE TO CIRCUIT LP-25. TYPICAL FOR EACH FLOOR.
- CONTRACTOR SHALL USE (MODEL NO. BRK SC91205) COMBINATION OF SMOKE AND CO DETECTORS. DETECTOR INSTALLED MINIMUM 3'-0" FROM HVAC SUPPLY AIR DIFFUSERS.

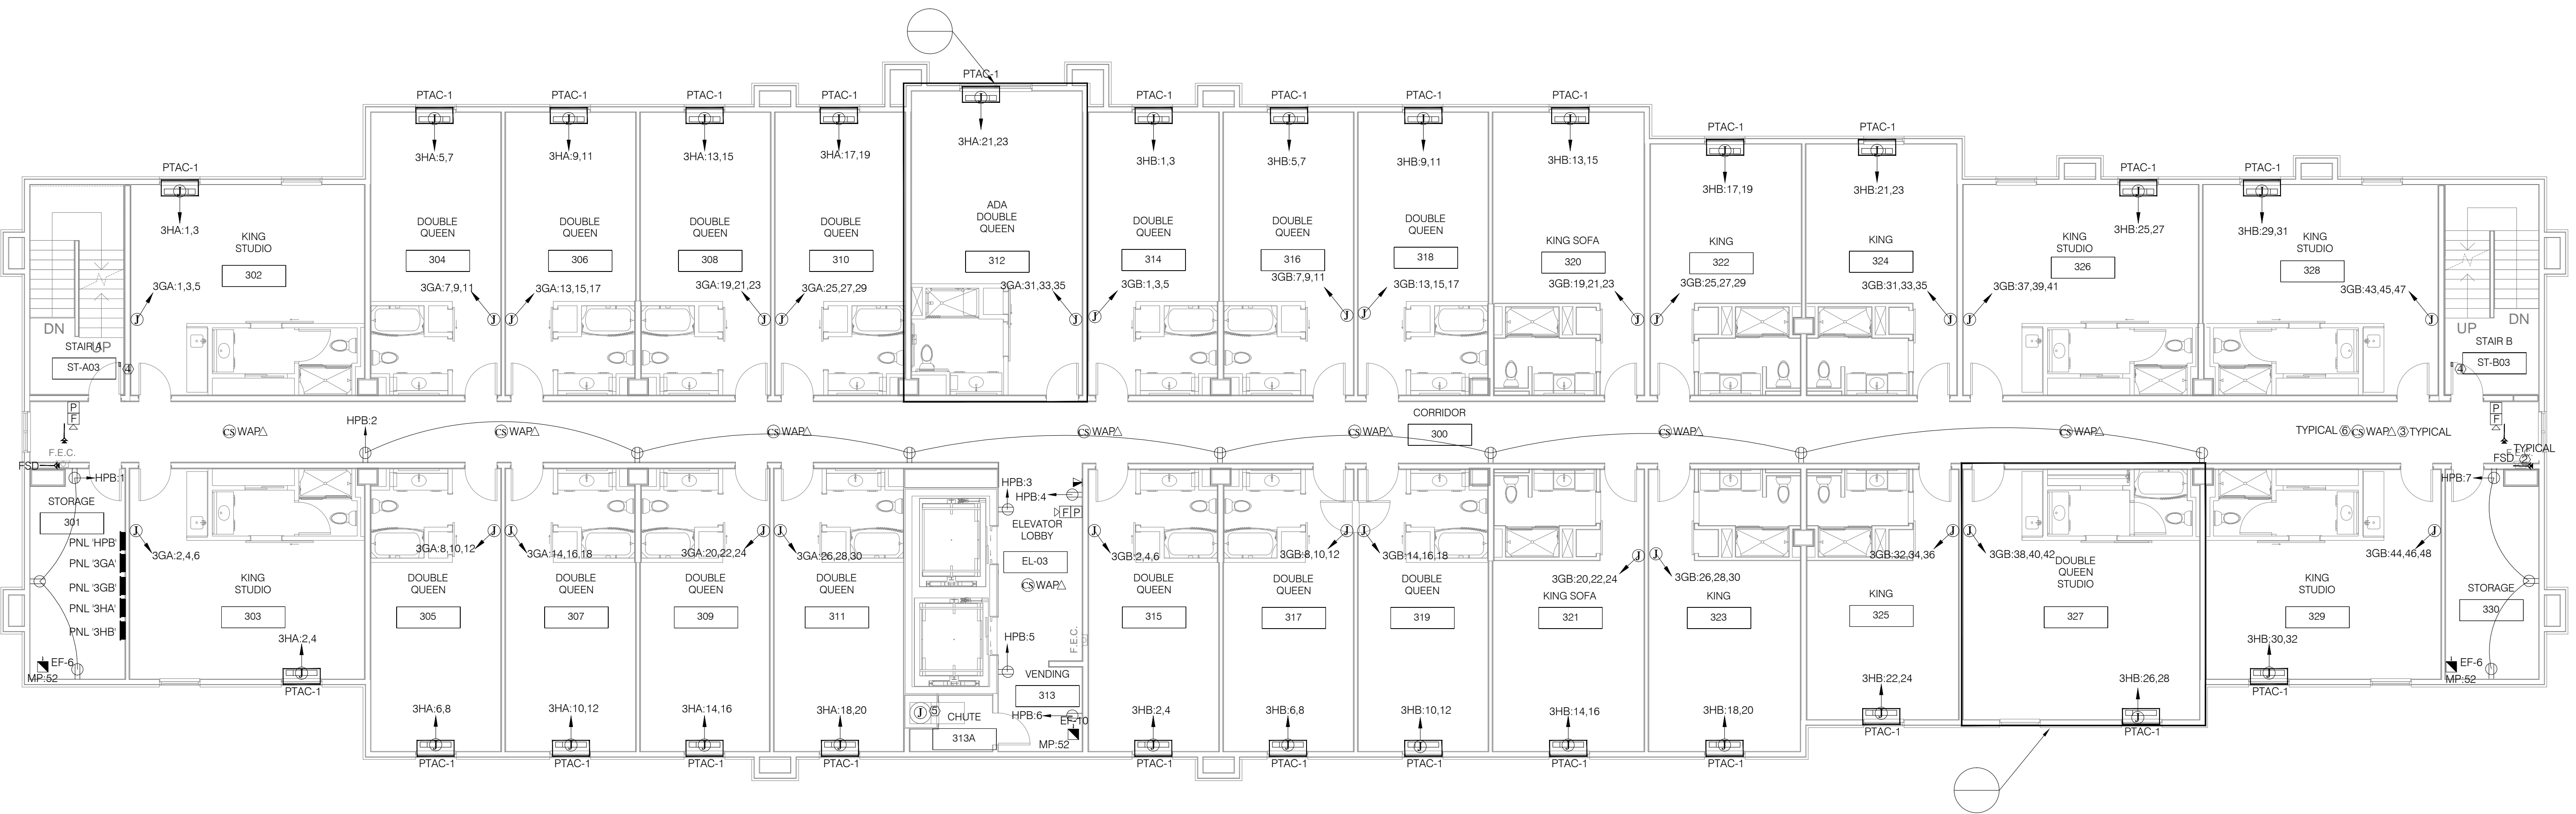

01 THIRD FLOOR POWER PLAN
SCALE: 3/32" = 1'-0"